


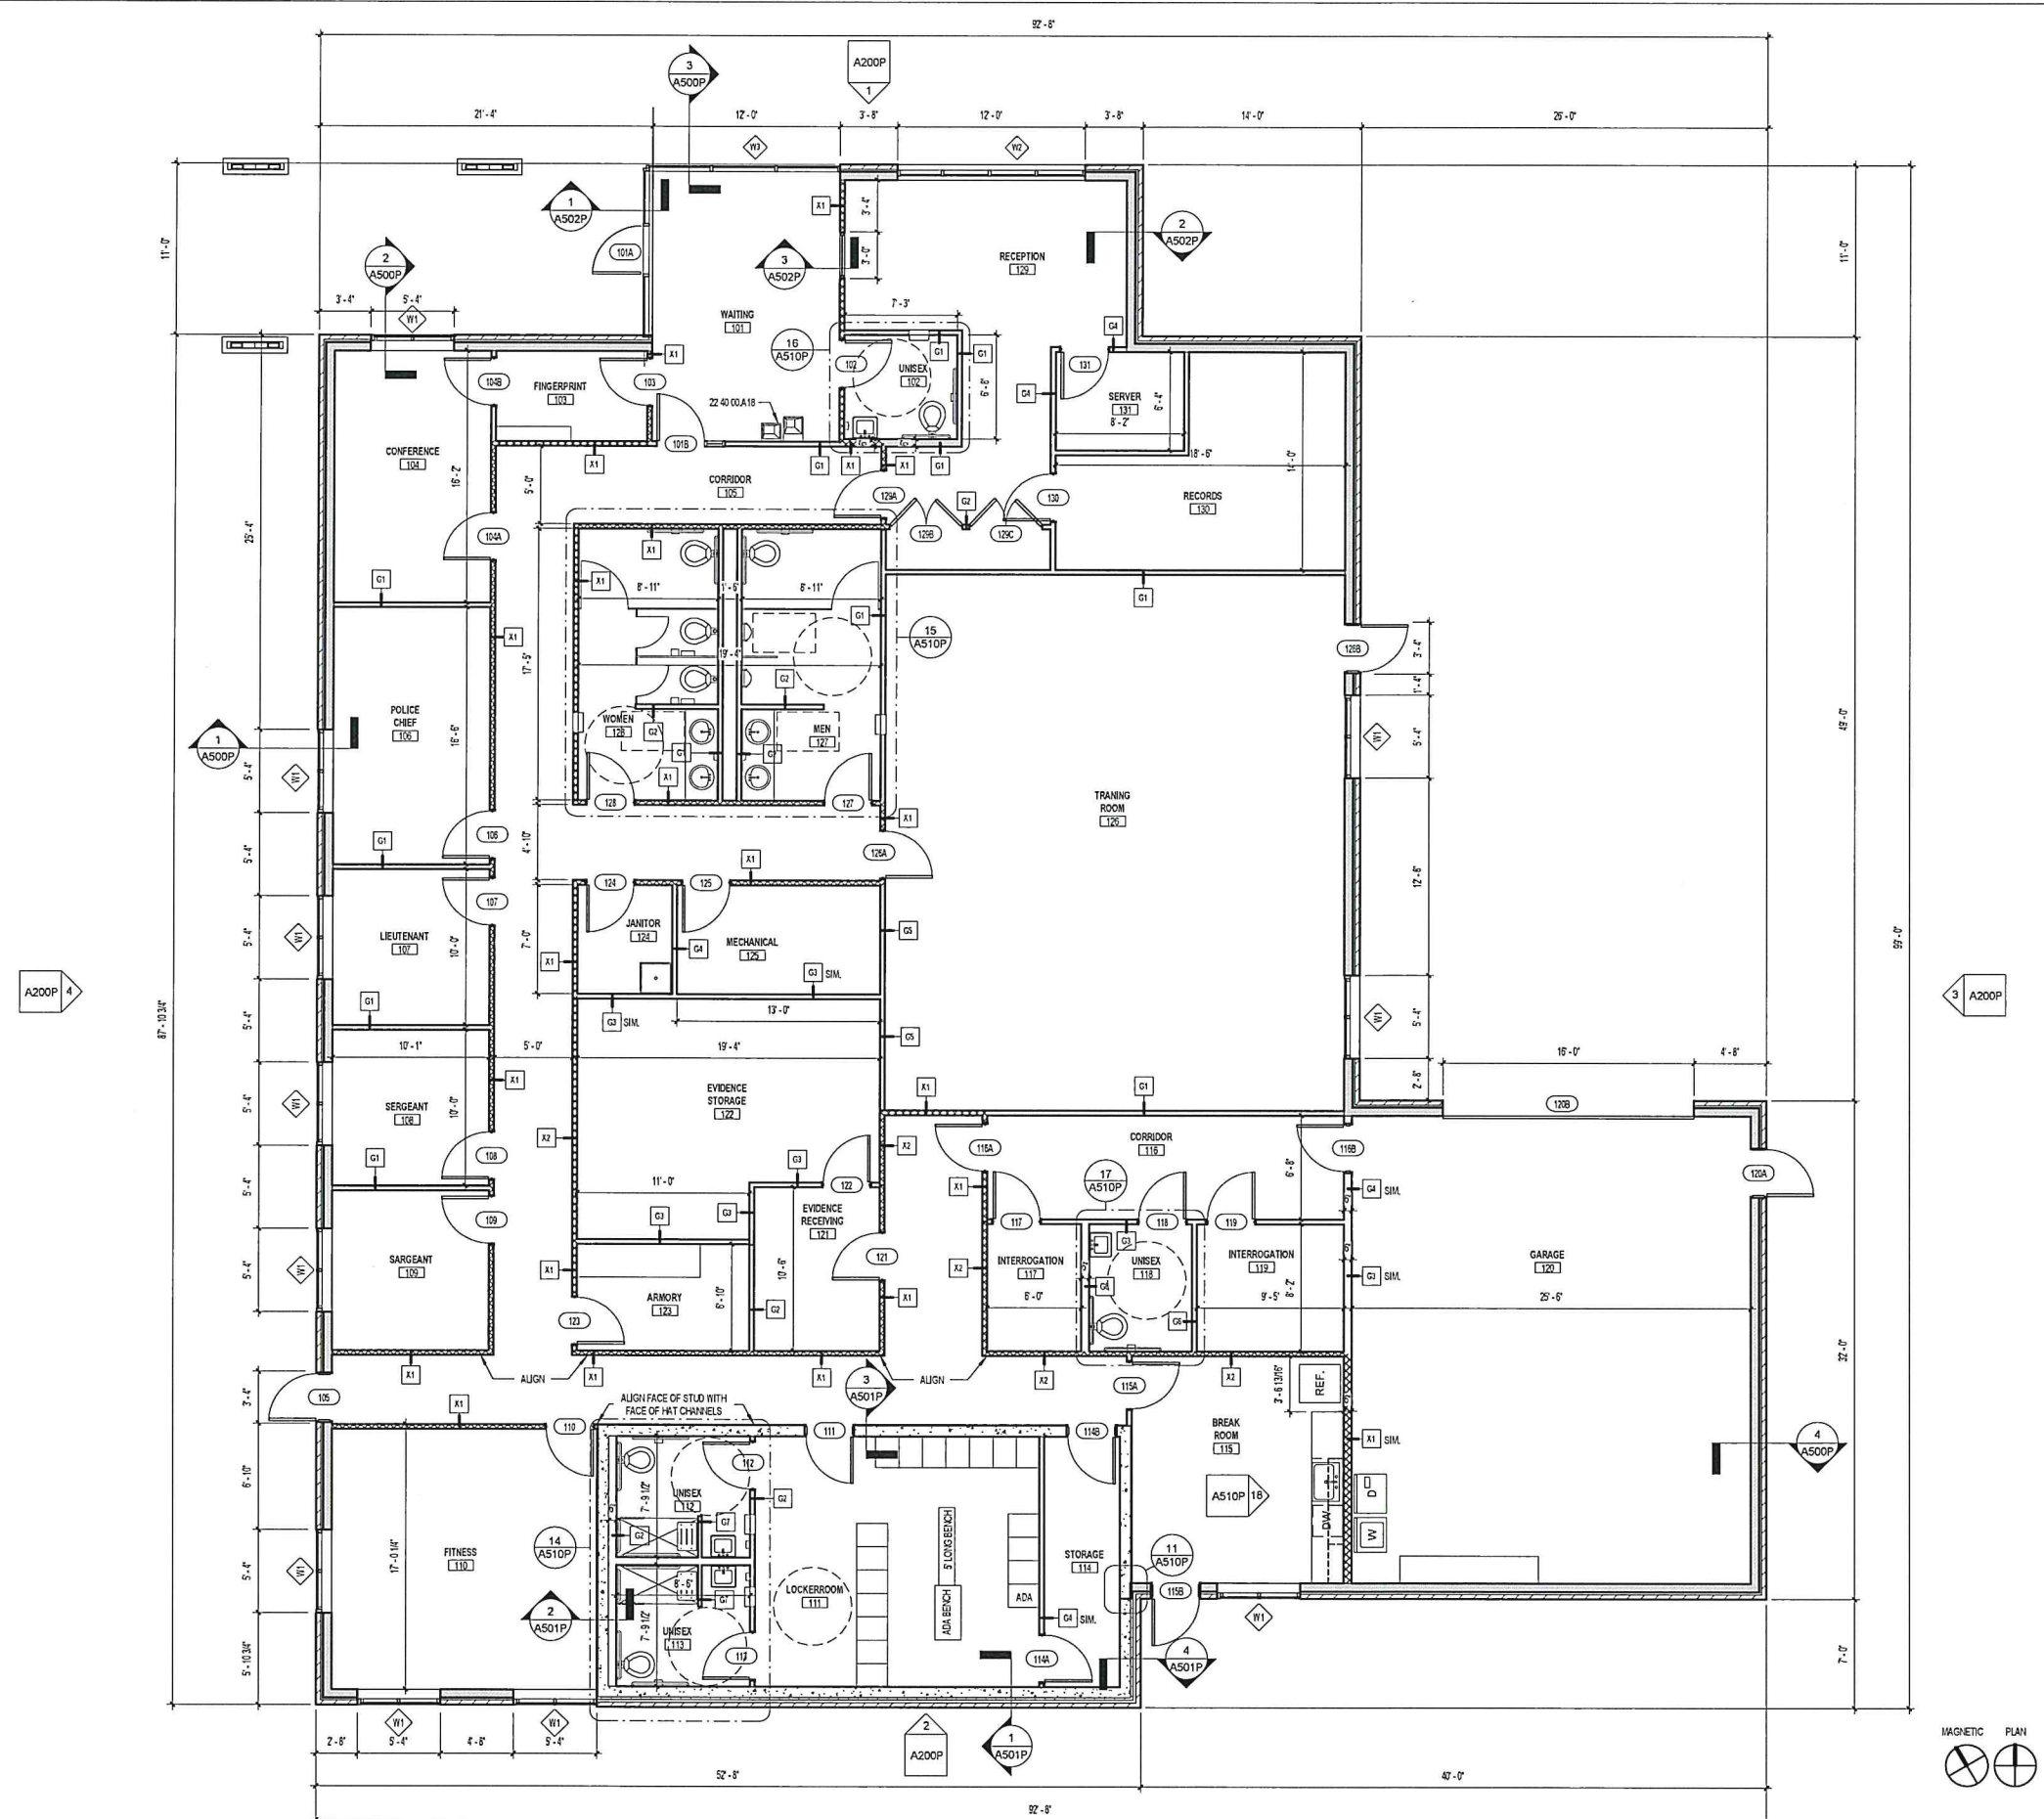

SHEET KEYNOTES
22 40 00 A18 Hi-Is drinking fountain with one ADA fixture. See MEP Drawings

PCA
ARCHITECTURE

1885 Dixie Highway, Suite 130
www.PCA-ARCH.com
859.431.8612

PROJECT # 2020-092

NOT FOR
CONSTRUCTION

Cold Spring - Police Department

5694 E. ALEXANDRIA PIKE
COLD SPRING, KY 41076

ISSUE	DATE	DESCRIPTION
	09/25/2020	DESIGN DEVELOPMENT

FLOOR PLAN

A100P


1 FLOOR PLAN
A200P SCALE: 3/16" = 1'-0"

PRINT DATE: 10/16/2020 2:15:49 PM




1 NORTH ELEVATION

A100P SCALE: 3/16" = 1'-0"

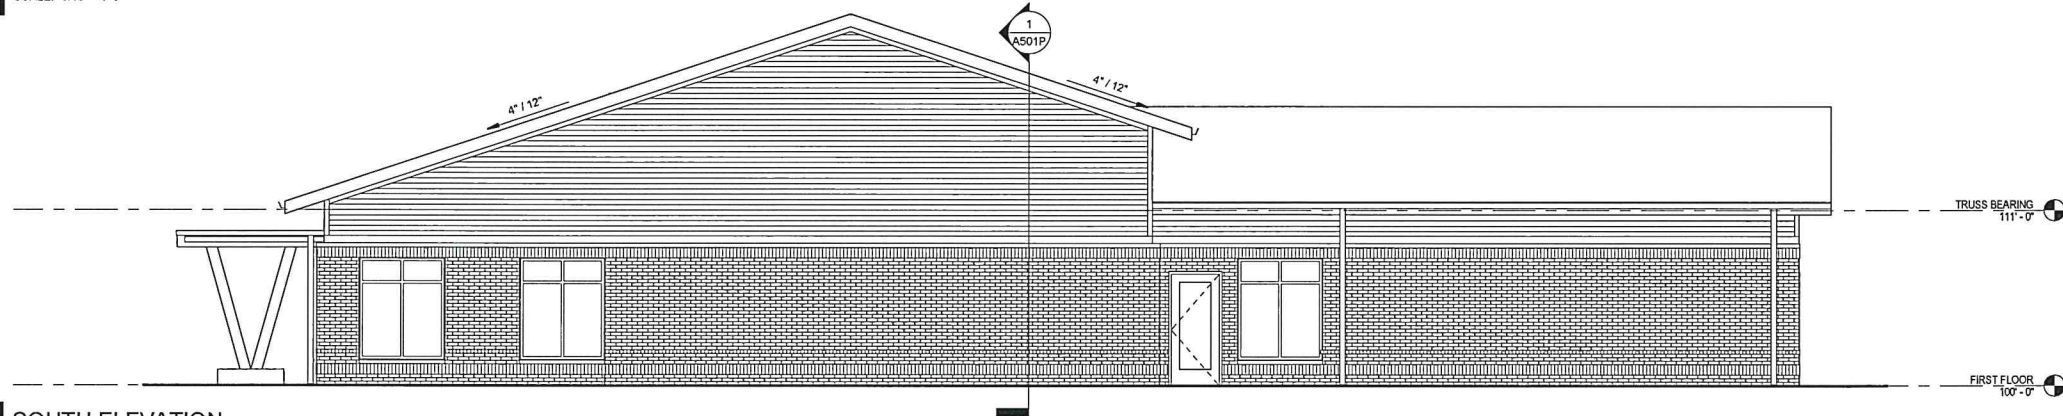


2 SOUTH ELEVATION

A100P SCALE: 3/16" = 1'-0"

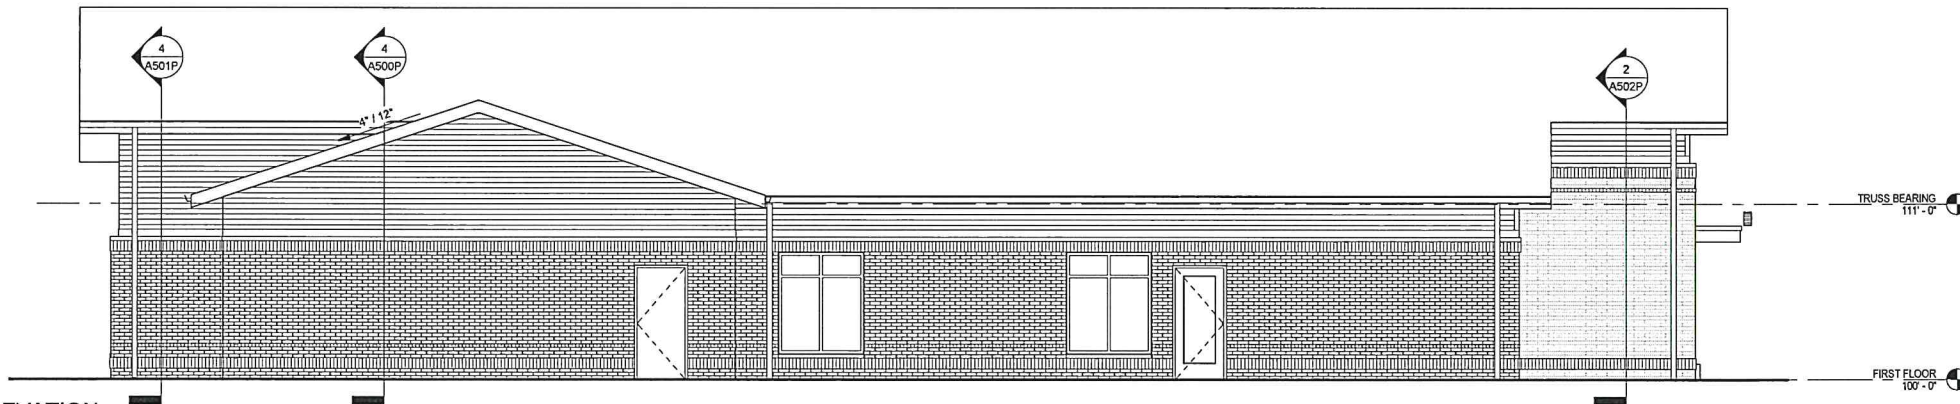

3 EAST ELEVATION

A100P SCALE: 3/16" = 1'-0"

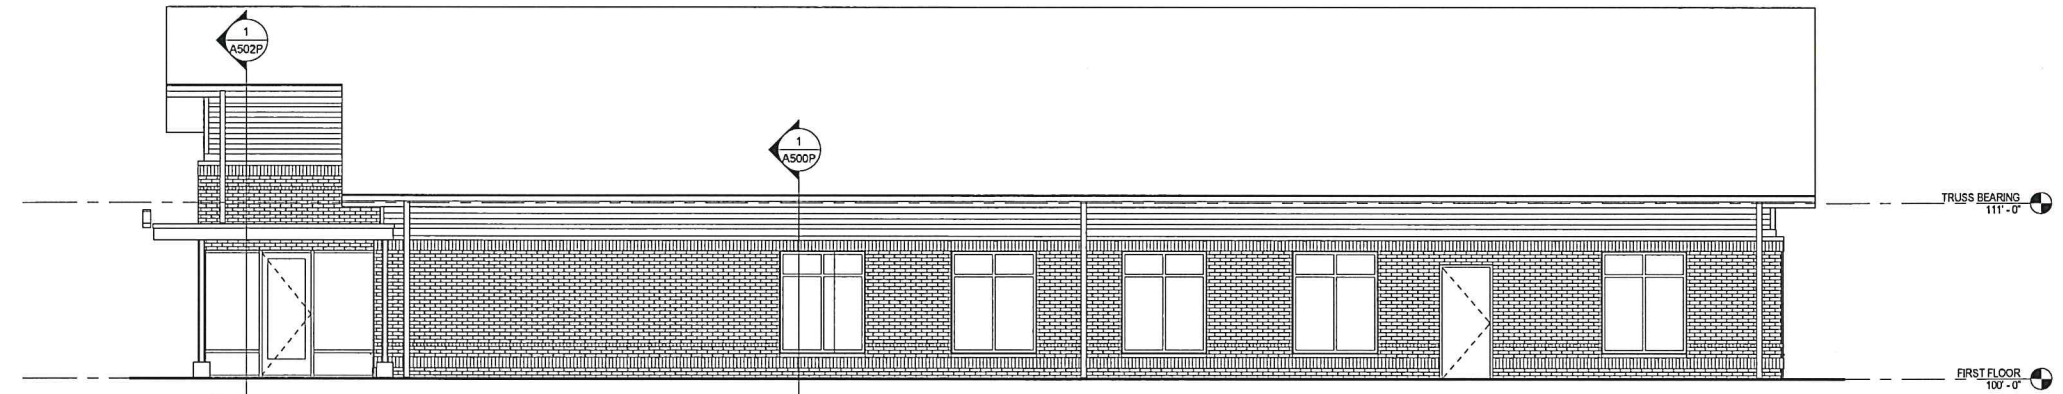

4 WEST ELEVATION

A100P SCALE: 3/16" = 1'-0"

PCA
ARCHITECTURE

1885 Dixie Highway, Suite 130
www.PCA-ARCH.com
859.431.8612

PROJECT # 2020-092

NOT FOR
CONSTRUCTION

Cold Spring - Police Department

5694 E. ALEXANDRIA PIKE
COLD SPRING, KY 41076

ISSUE	DATE	DESCRIPTION
	09/25/2020	DESIGN DEVELOPMENT

BUILDING
ELEVATIONS

A200P